


MANHOLE 27 TO MANHOLE 24 (BASELINE B)
PLAN

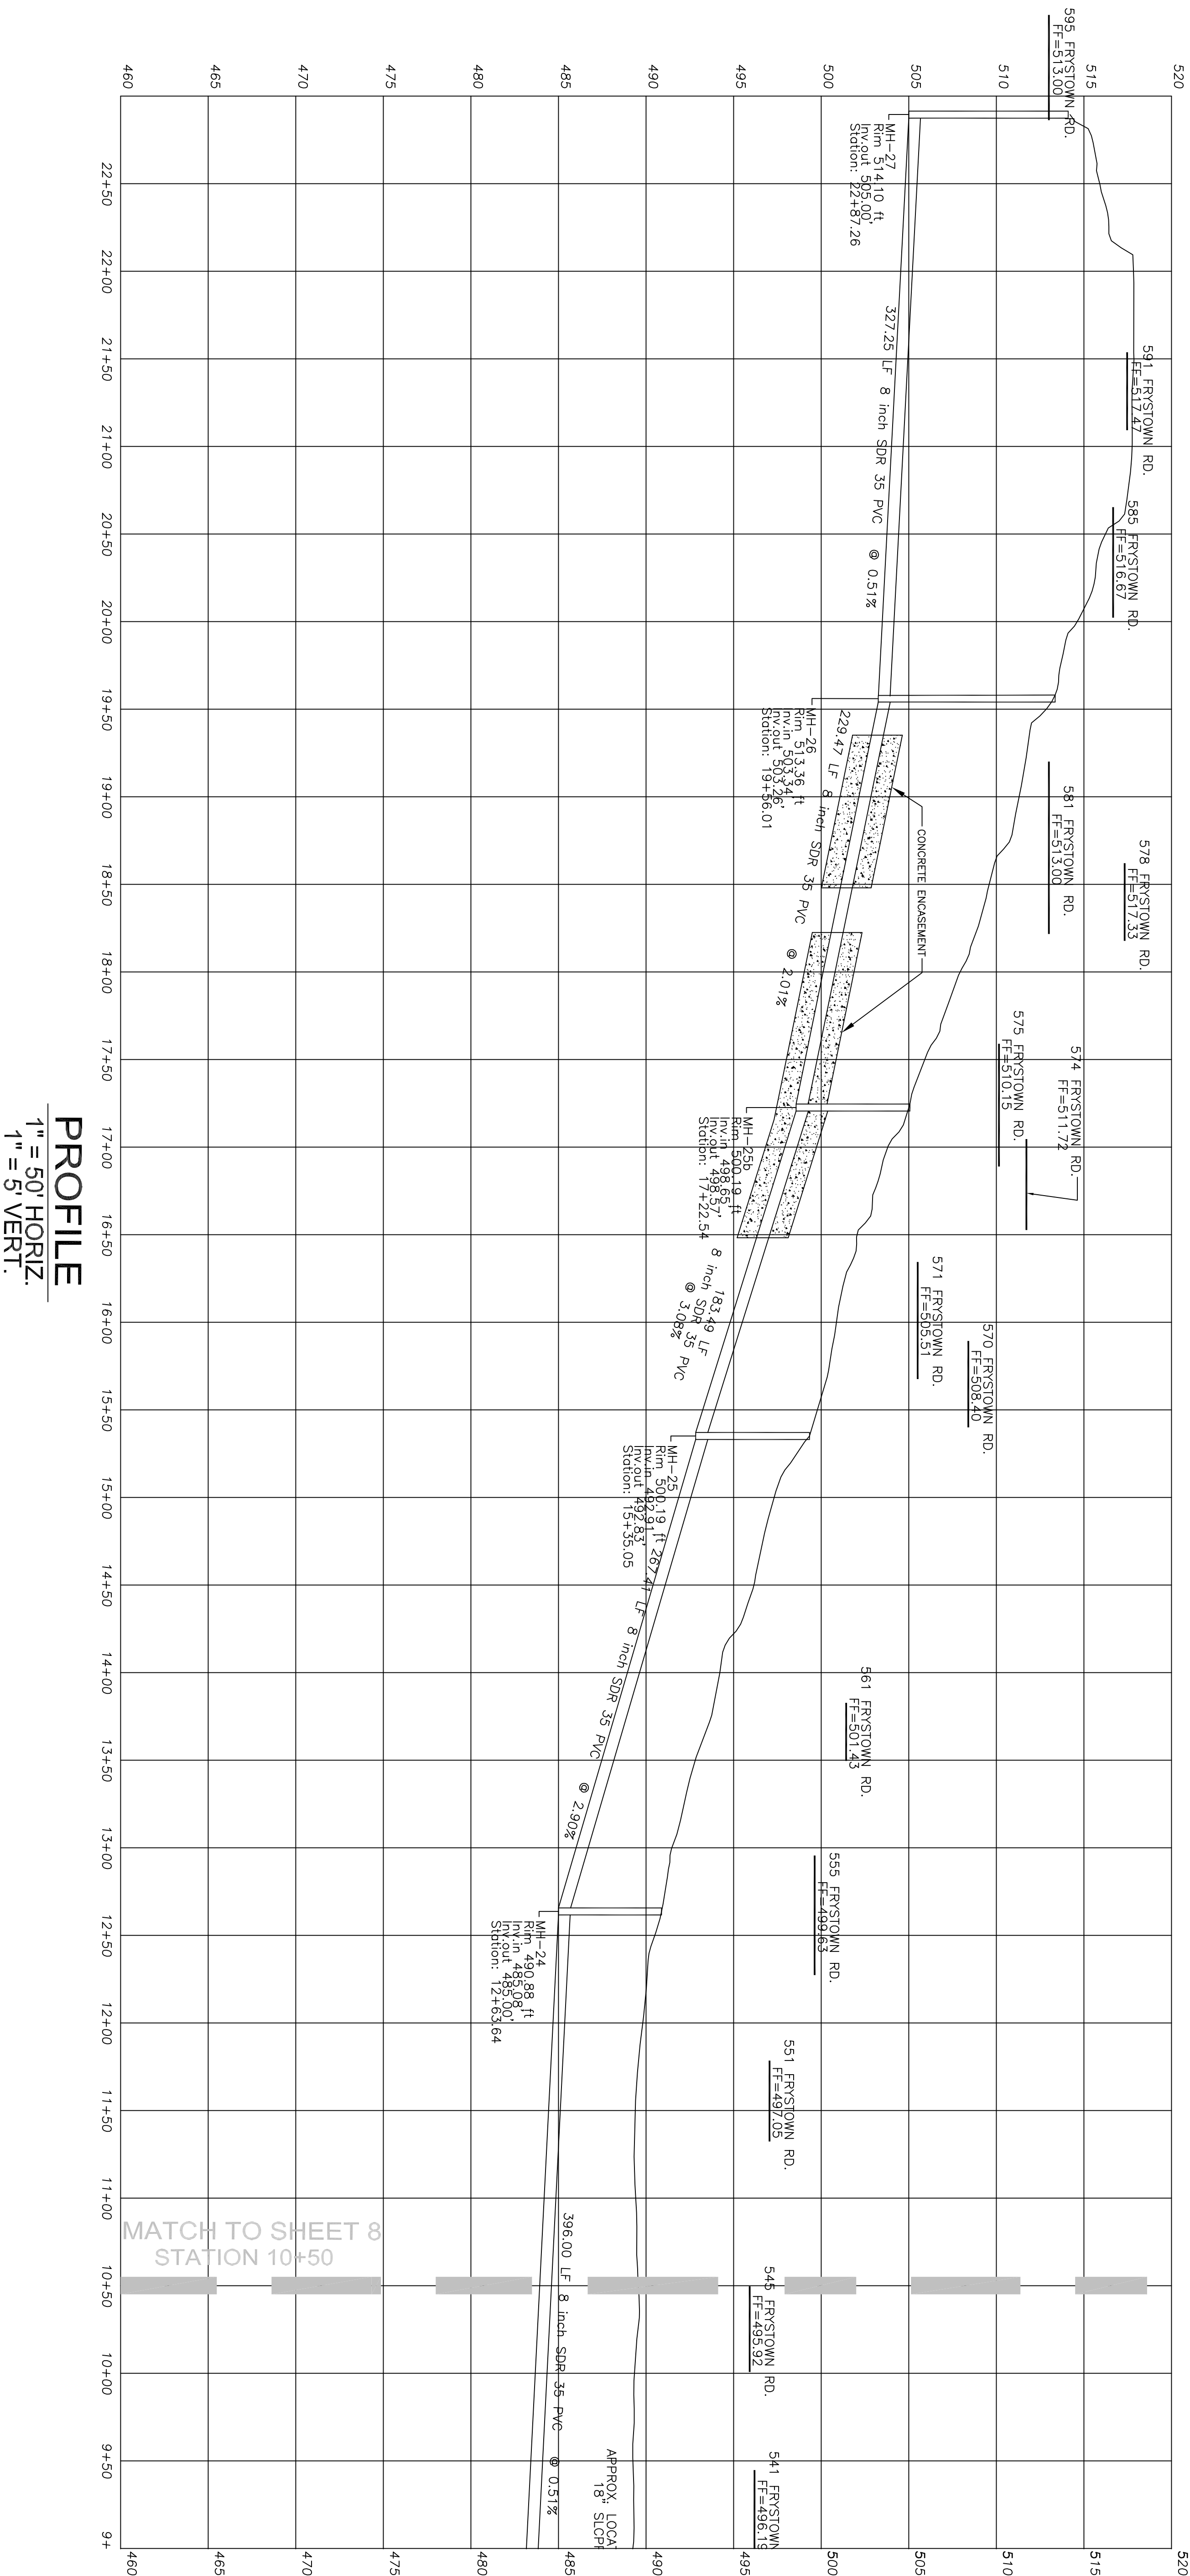

 
PROFILE
1" = 50' HORIZ.
1" = 5' VERT.

VISION ENGINEERING, INC.
CIVIL - SITE - MUNICIPAL
155 E. FRONT ST. - LITITZ, PA 17543
TEL. (717) 625-1930 FAX (717) 625 1931

PROJECT TITLE
SANITARY SEWER PLANS
COLLECTION & CONVEYANCE LINES
FOR
THE VILLAGE OF FRYSTOWN
BETHEL TOWNSHIP BERKS COUNTY, PA

SHEET TITLE
PLAN AND PROFILE
(SHEET 4 of 9)

CLIENT
BETHEL TOWNSHIP
MUNICIPAL AUTHORITY
P.O. BOX 24
BETHEL, PA 19507
(717) 933-8813



MANAGER:
JOHN K. ROCHE
DESIGN BY: BSC/ASC
CHECKED BY: JKR
DRAWN BY: JTB/ACH
CHECKED BY: JKR

SEAL
JOHN K. ROCHE
PE-053824-E

NO	DATE	REVISION
1	2/28/08	EASEMENT REVISION