



MANHOLE 19 TO 39 (BASELINE C)

PLAN

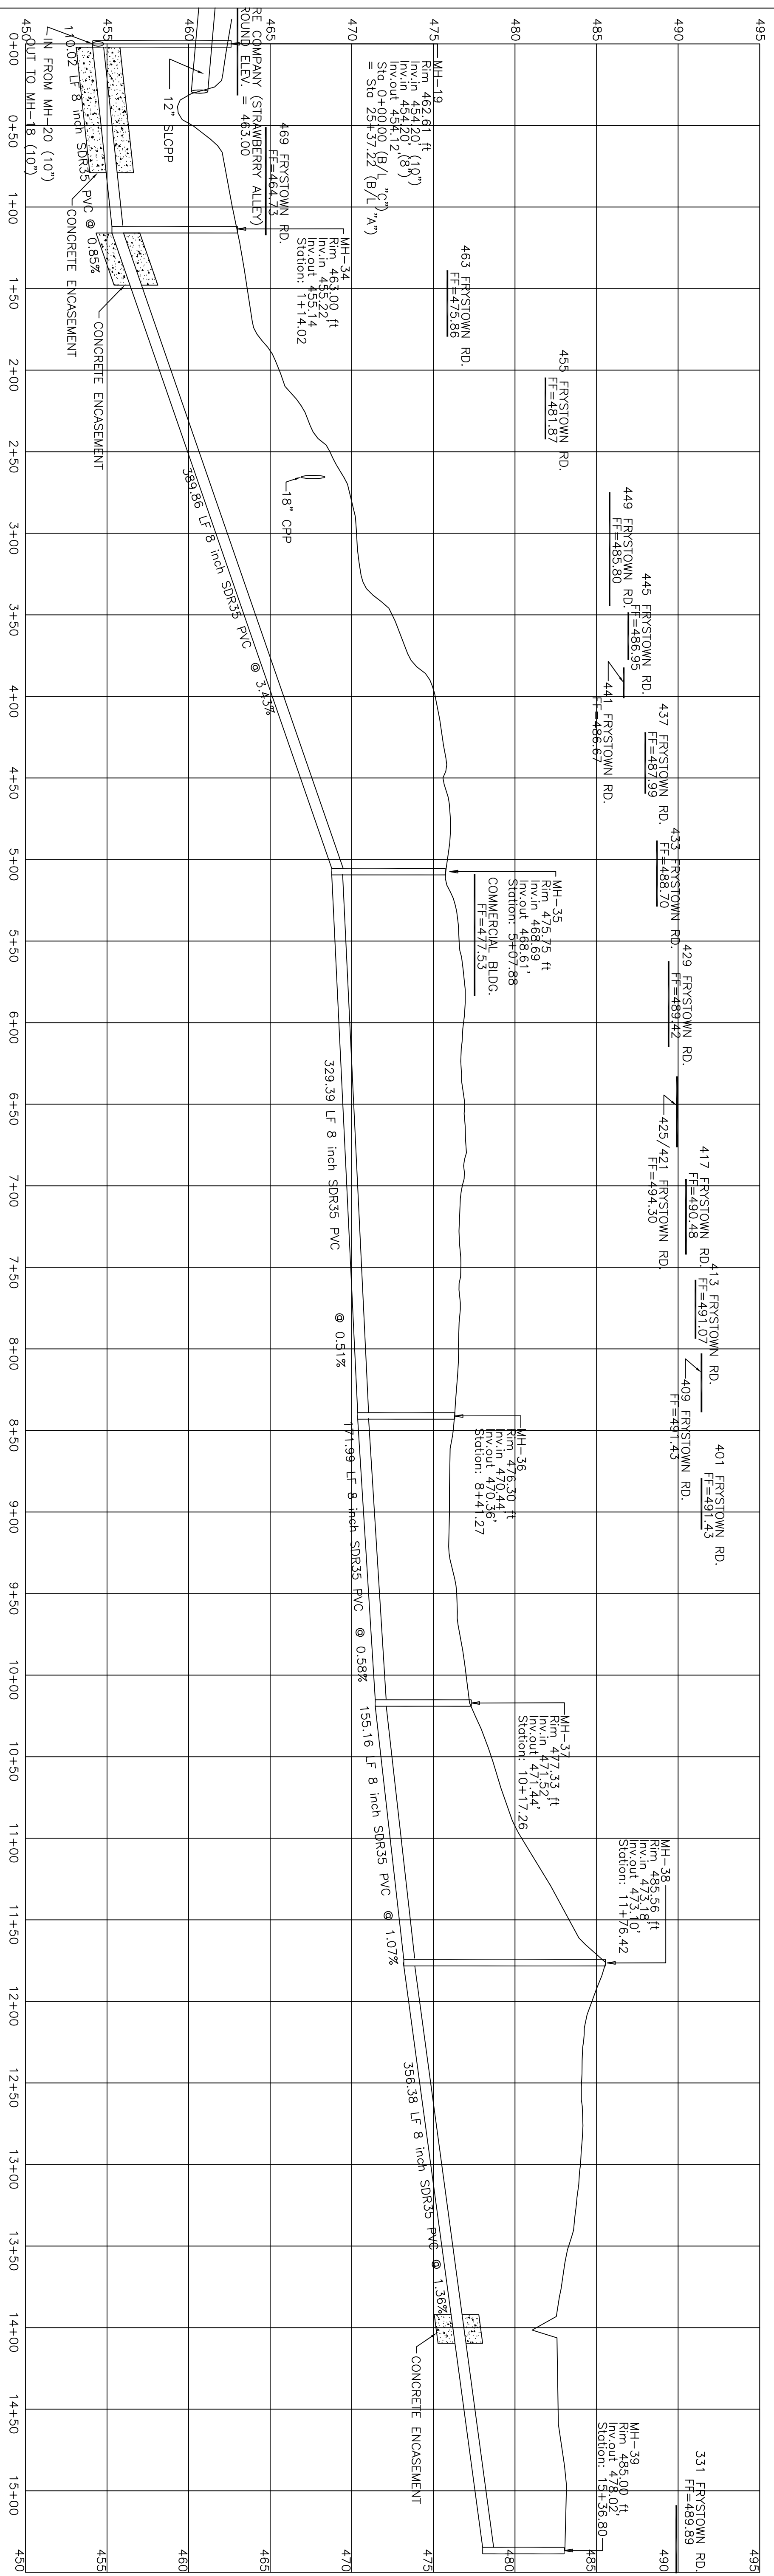

PROFILE

1" = 50' HORIZ.
1" = 5' VERT.

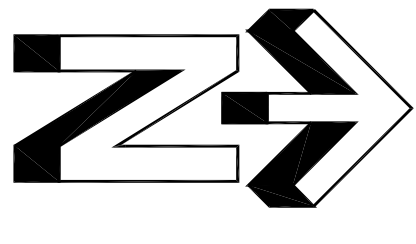

<p>VISION ENGINEERING, INC. CIVIL - SITE - MUNICIPAL 155 E. FRONT ST. - LITITZ, PA 17543 TEL. (717) 625-1930 FAX (717) 625 1931</p>	<p>PROJECT TITLE SANITARY SEWER PLANS COLLECTION & CONVEYANCE LINES FOR THE VILLAGE OF FRYSTOWN BETHEL TOWNSHIP BERKS COUNTY, PA</p>	<p>CLIENT BETHEL TOWNSHIP MUNICIPAL AUTHORITY P.O. BOX 24 BETHEL, PA 19507 (717) 933-8813</p>	<p>MANAGER: JOHN K. ROCHE</p> <p>DESIGN BY: BSC/ASC CHECKED BY: JKR</p> <p>DRAWN BY: JTB/ACH CHECKED BY: JKR</p>	<p>SEAL JOHN K. ROCHE PE-053824-E</p>	<p>SEAL</p>	<table border="1"> <tr> <th>NO</th> <th>DATE</th> <th>REVISION</th> </tr> <tr> <td>1</td> <td>2/28/08</td> <td>EASEMENT REVISION</td> </tr> </table>	NO	DATE	REVISION	1	2/28/08	EASEMENT REVISION
	NO	DATE	REVISION									
1	2/28/08	EASEMENT REVISION										
<p>SHEET TITLE PLAN AND PROFILE (SHEET 6 of 9)</p>	<p>SCALE 1" = 50'</p>	<p>DATE: JULY 3, 2006 PROJECT NO.: BTMA-0302 SHEET NO.: 9 OF 31</p>										